


SITE PLAN
Scale 1:200

- LEGEND:**
- SMOKE DETECTOR
 - HARD WIRED INTERLINKED 250mm EXHAUST FAN
 - METER BOX
 - GAS METER
 - HOT WATER SERVICE
 - DOWN PIPE
 - EXISTING DOWN PIPE
 - SPREADER PIPE
 - RAINWATER HEAD
 - NATURAL GROUND LEVEL
 - FINISHED FLOOR LEVEL
 - CEILING LEVEL
 - ARTICULATION JOINT
 - FLOOR WASTE
 - CERAMIC/PORCELAIN TILES
 - STORAGE
 - CONCRETE
 - RETURN AIR
 - RAIN WATER TANK




GROUND FLOOR PLAN
Proposed Scale 1:100

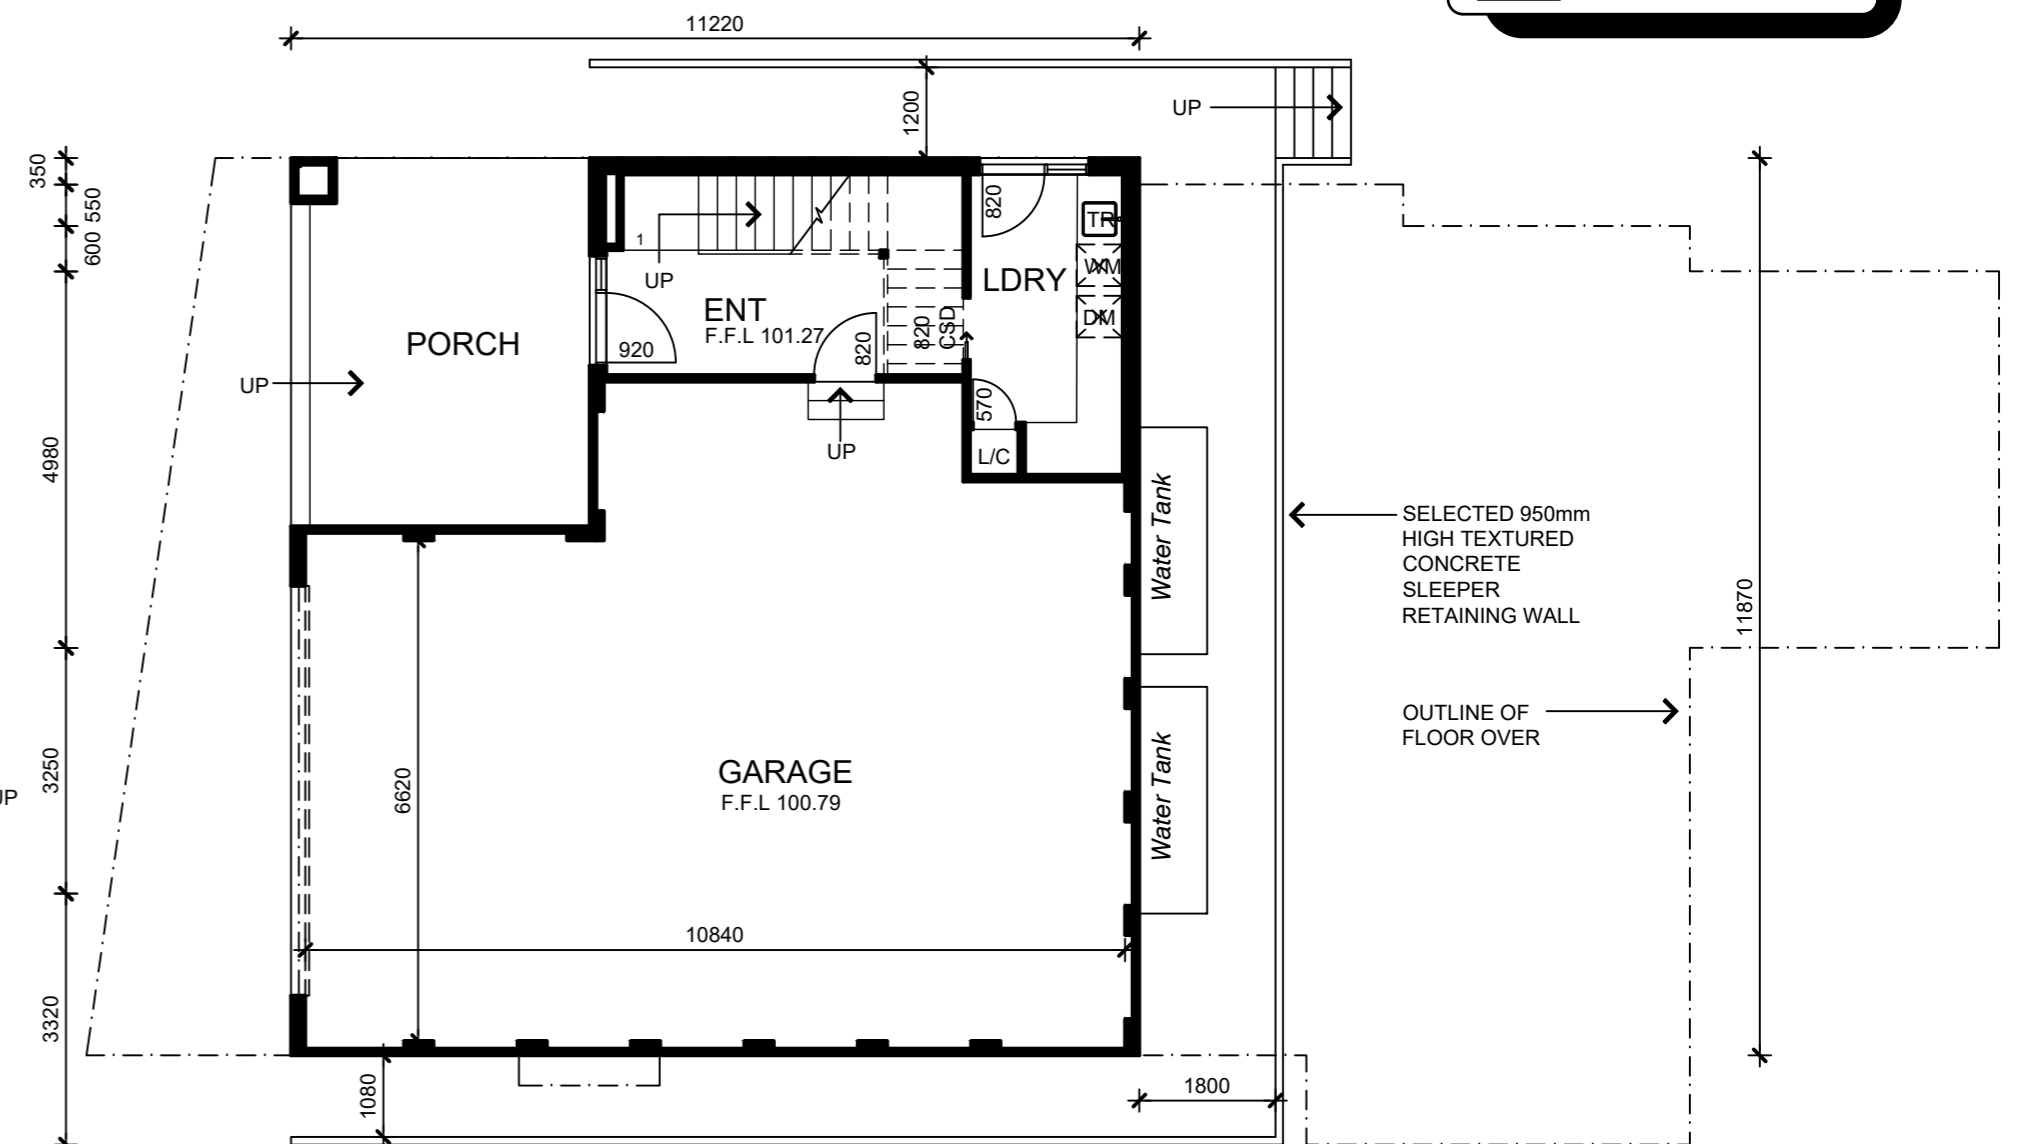


LOWER FLOOR PLAN
Proposed Scale 1:100

REV	DESCRIPTION	CHK	DATE
B	PRELIMINARY ISSUE FOR TOWN PLANNING APPROVAL	W.P.	24.08.2020

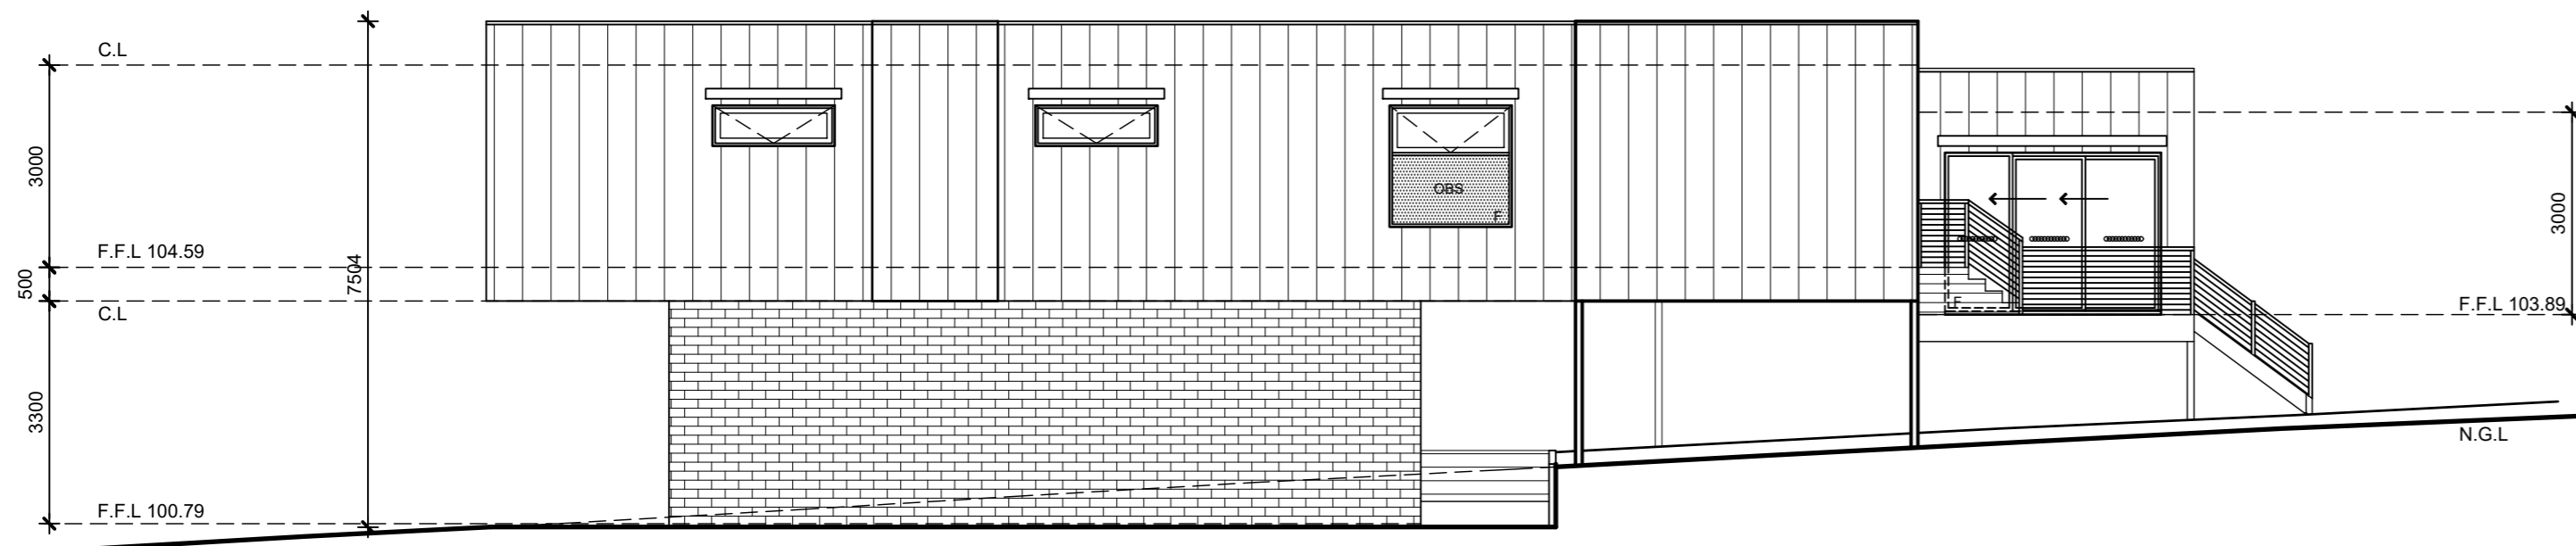


SOUTH WEST ELEVATION
Scale 1:100

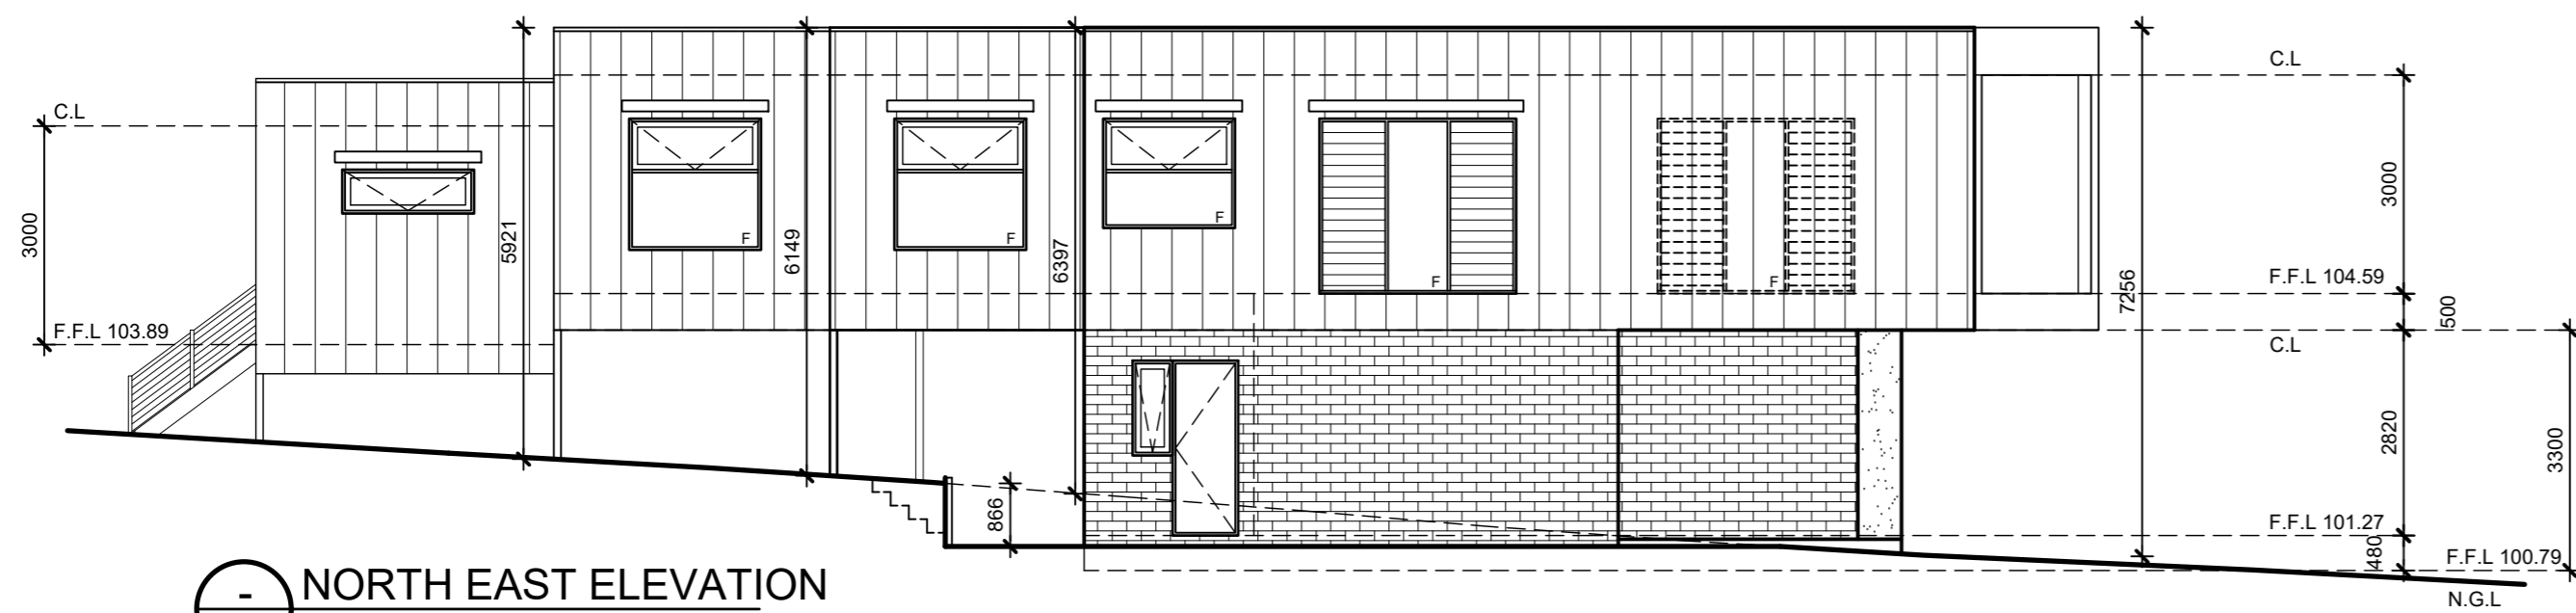

NORTH EAST ELEVATION
Scale 1:100



SOUTH EAST ELEVATION
Scale 1:100

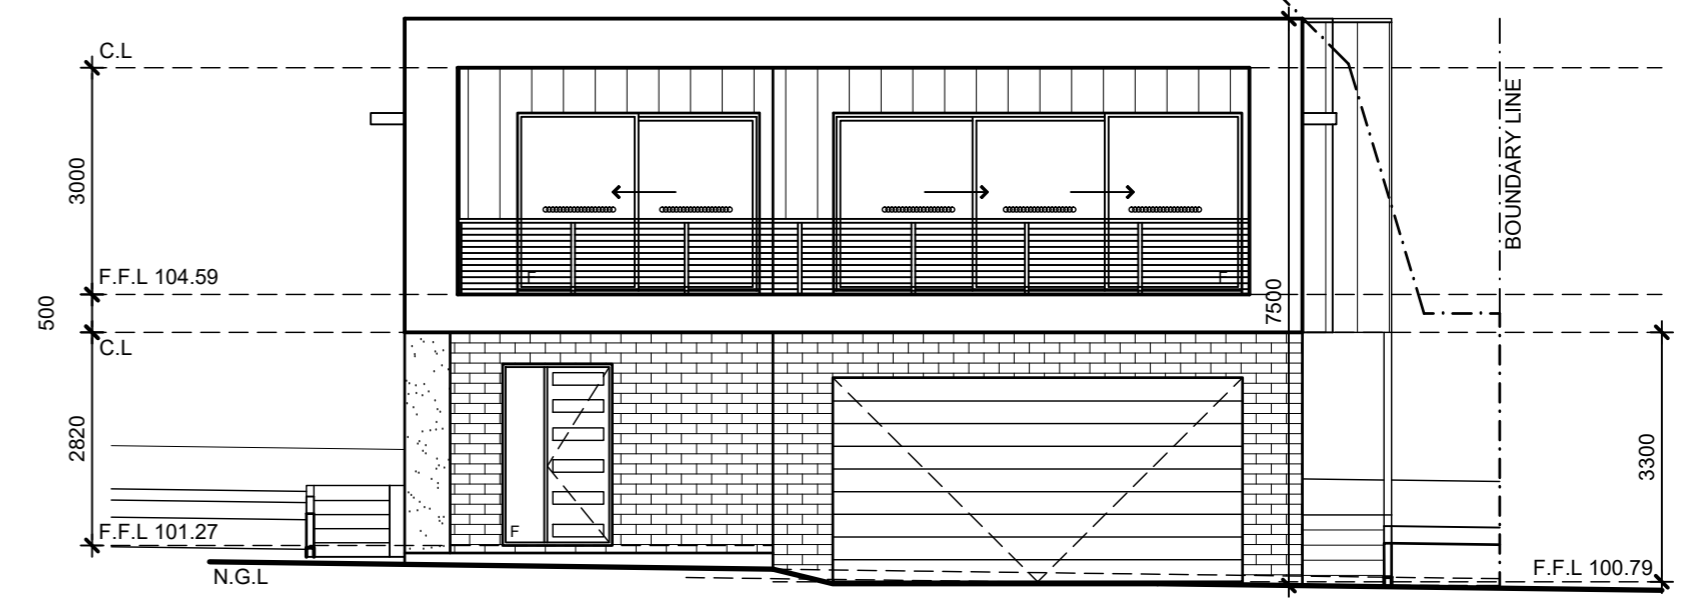

NORTH WEST ELEVATION
Scale 1:100

LEGEND:

	SMOKE DETECTOR
	HARD WIRED INTERLINKED 250mm EXHAUST FAN
	METER BOX
	GAS METER
	HOT WATER SERVICE
	DOWN PIPE
	EXISTING DOWN PIPE
	SPREADER PIPE
	RAINWATER HEAD
	NATURAL GROUND LEVEL
	FINISHED FLOOR LEVEL
	CEILING LEVEL
	ARTICULATION JOINT
	FLOOR WASTE
	CERAMIC/PORCELAIN TILES
	STORAGE
	CONCRETE
	RETURN AIR
	RAIN WATER TANK



T/F: 9739 4710 M: 0419 379 858
E: pryorplans@bigpond.com
Registered Building Practitioner
DP-AD 32333

REV	DESCRIPTION	BY	CHK	DATE
B	PRELIMINARY ISSUE FOR TOWN PLANNING APPROVAL	W.P	W.P	24.08.2020

FOR	LEIGH & STEPHANIE SMITH	JOB No.	9220
PROJECT	PROPOSED RESIDENCE AT 13 VENTNOR BOULEVARD, VENTNOR	SCALE	AS NOTED
TITLE	ELEVATIONS	SHEET	2